


R:\RCA Job Files\19784\19784_19784 - Storage Buildings at Haverfordwest\19784-03.dwg
RCA Document Reference: RCA A1 Landscape Version 1
07/05/2017 09:58:00

DO NOT SCALE

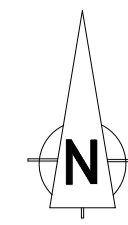


NOTES:

THE PROPERTY OF THIS DRAWING AND DESIGN IS VESTED IN ROGER CASEY ASSOCIATES AND MUST NOT BE COPIED OR REPRODUCED IN ANY WAY WITHOUT THE WRITTEN CONSENT OF ROGER CASEY ASSOCIATES.

THE CONTRACTOR IS TO CHECK ALL LEVELS AND DIMENSIONS BEFORE WORK COMMENCES, AND ANY DISCREPANCIES TO BE REPORTED IMMEDIATELY TO THE CONSULTANTS.

WORK TO FIGURED DIMENSIONS IN PREFERENCE TO SCALING.

THIS DRAWING IS TO BE READ IN CONJUNCTION WITH ALL OTHER ROGER CASEY ASSOCIATES DRAWINGS AND SPECIFICATIONS AND ALL OTHER CONSULTANTS DRAWINGS AND SPECIFICATIONS RELATING TO THIS PROJECT.

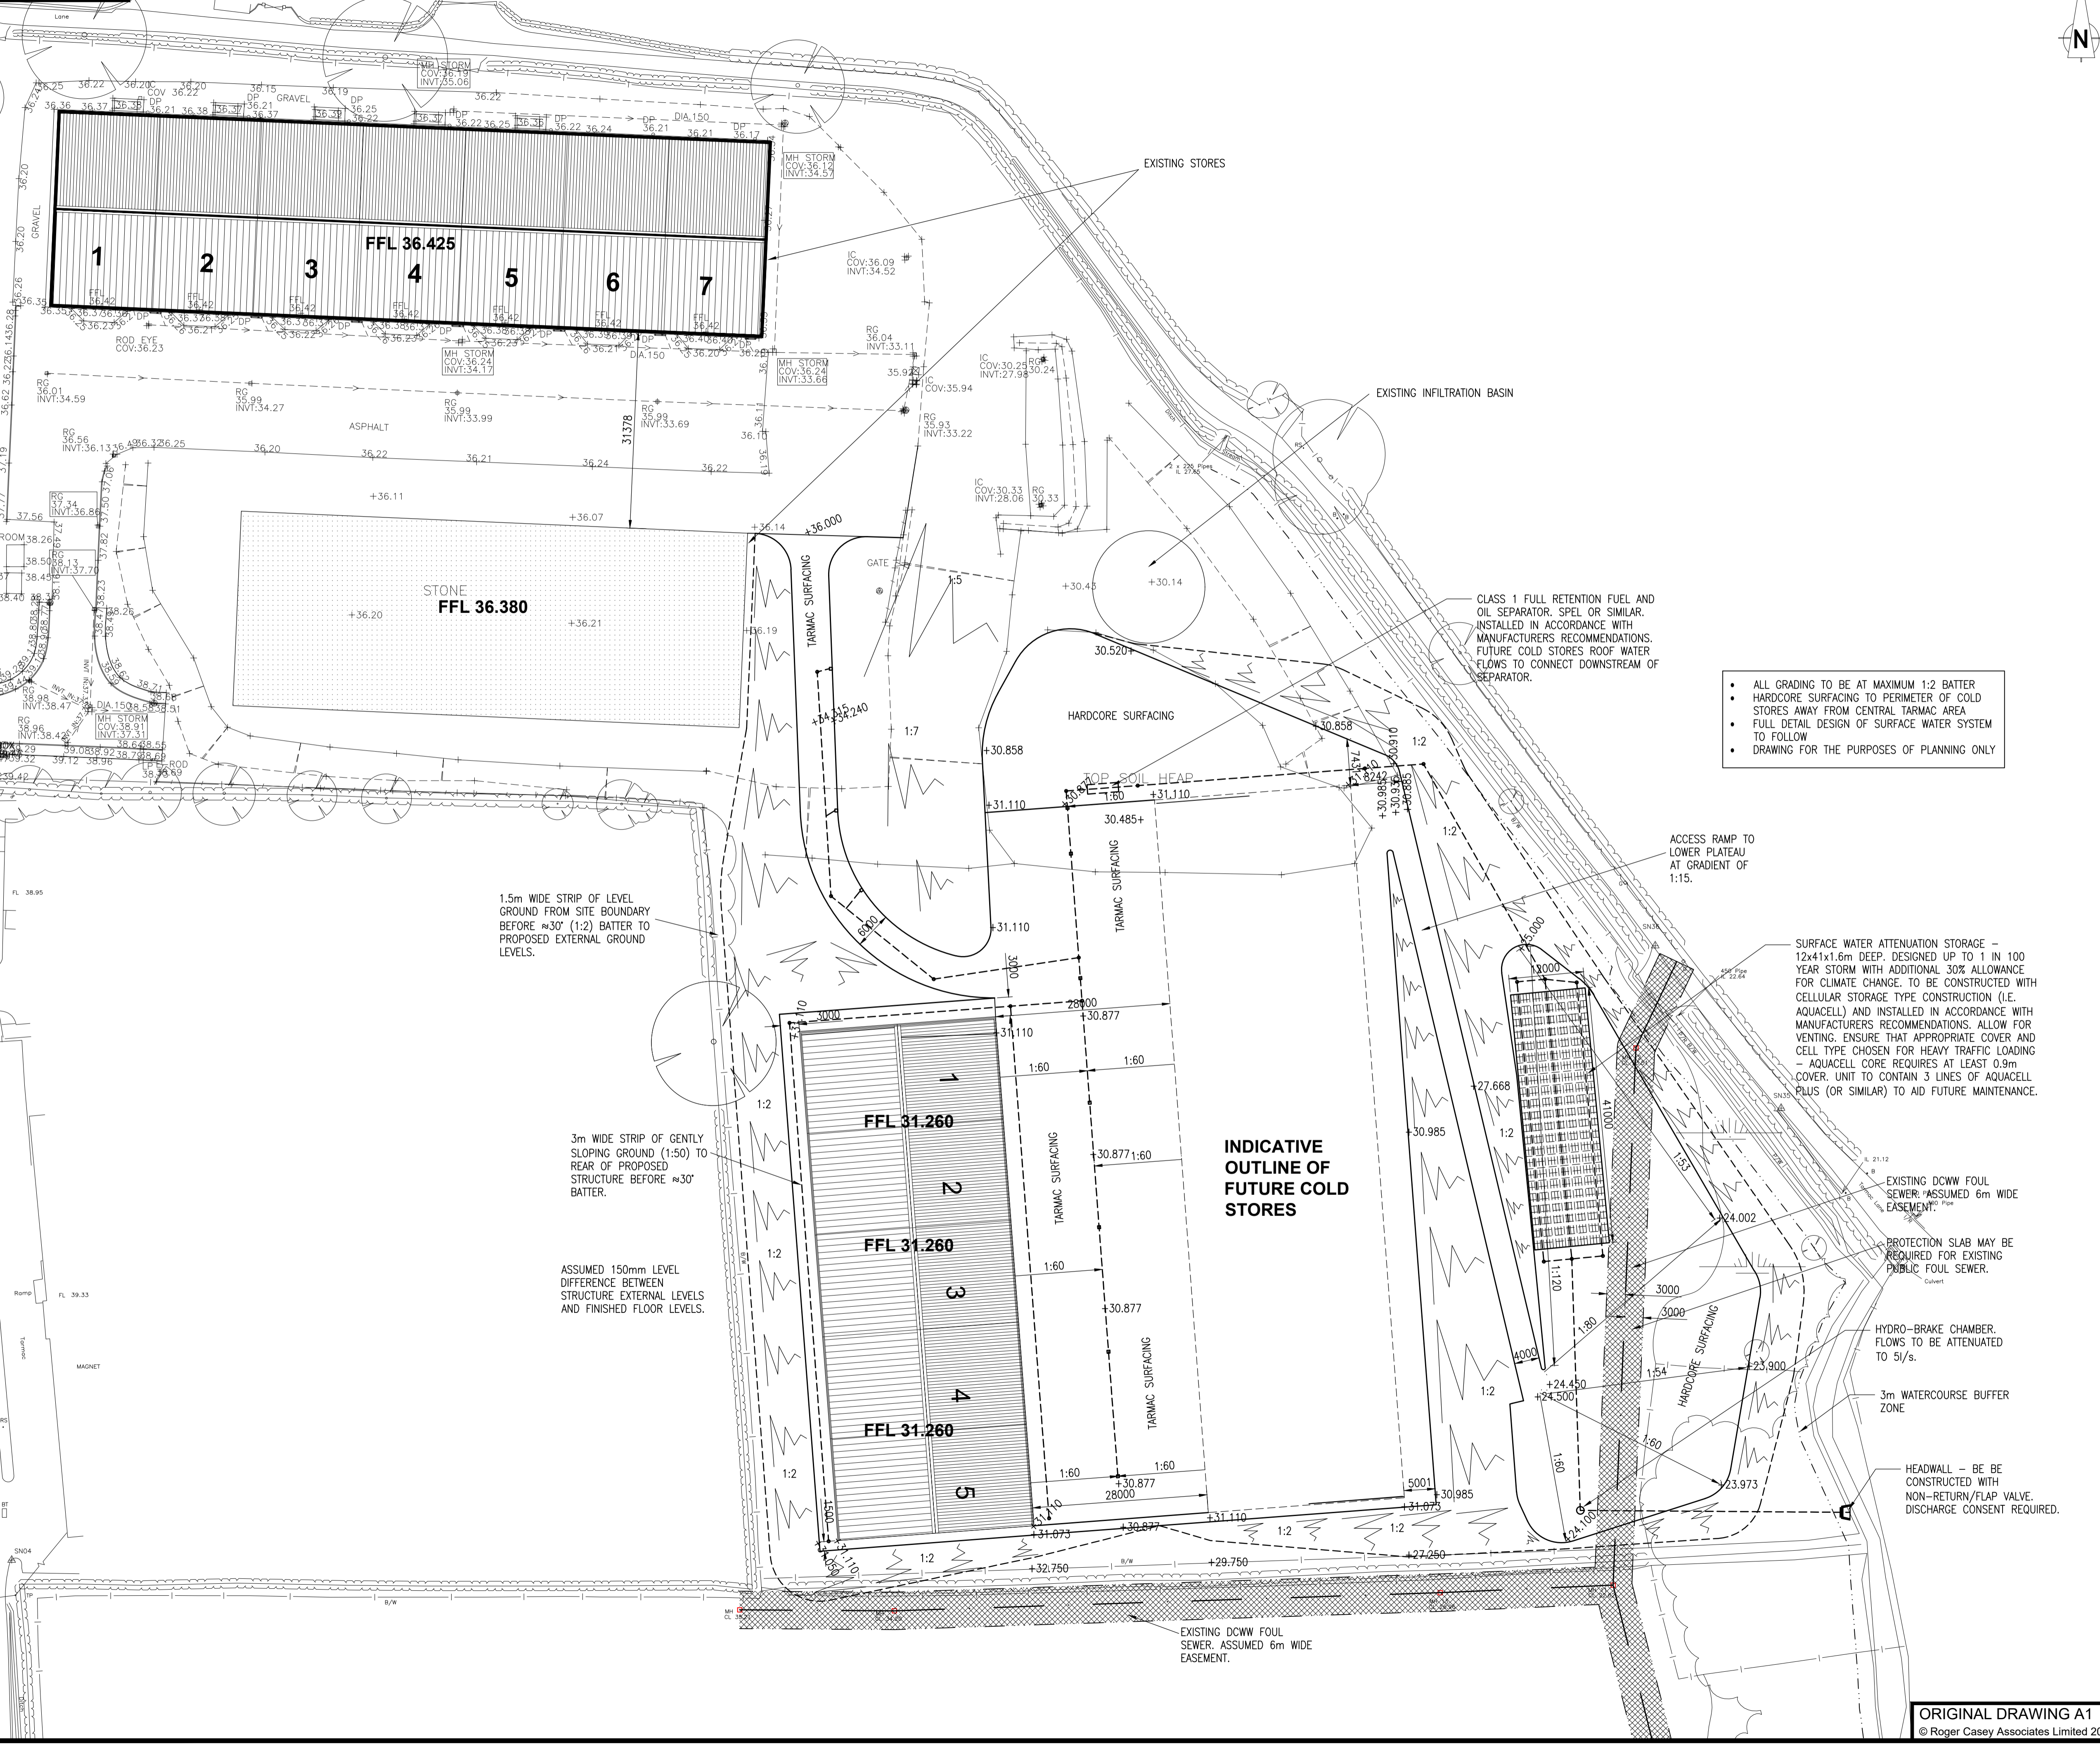

- ALL GRADING TO BE AT MAXIMUM 1:2 BATTER
- HARDCORE SURFACING TO PERIMETER OF COLD STORES AWAY FROM CENTRAL TARMAC AREA
- FULL DETAIL DESIGN OF SURFACE WATER SYSTEM TO FOLLOW
- DRAWING FOR THE PURPOSES OF PLANNING ONLY

REV	DESCRIPTION	DRAWN BY	CHECKED BY	DATE
A	7 BAY COLD STORE OUTLINED, STATUS CHANGE TO PLANNING	GWP	RSC	07/05/17

PLANNING

Roger Casey Associates
Consulting Civil & Structural Engineers

Ty Mansel, 6 Mansel Street, Carmarthen, Carmarthenshire SA31 1PX
T: 01267 222 646

Units 10 & 11, Merlin's Court, Winch Lane, Haverfordwest, Pembrokeshire SA61 1SB
T: 01437 762 795

E: office@rca-eng.co.uk
W: www.rca-eng.co.uk

CLIENT:

PUFFIN PRODUCE LTD

PROJECT:

PUFFIN PRODUCE WITHYBUSH INDUSTRIAL ESTATE HAVERFORDWEST, PEMBS.

DRAWING TITLE:

ENGINEERING SITE PLAN

DRAWN BY:	DESIGN BY:	CHECKED BY:	DATE:
GWP	GWP	RSC	16/05/17
SCALES:	DRAWING No.:	REVISION:	
1:500	19784/03	A	

ORIGINAL DRAWING A1
© Roger Casey Associates Limited 2016